


RIVER CAMPUS SUMMER 2024 PROJECT WORK

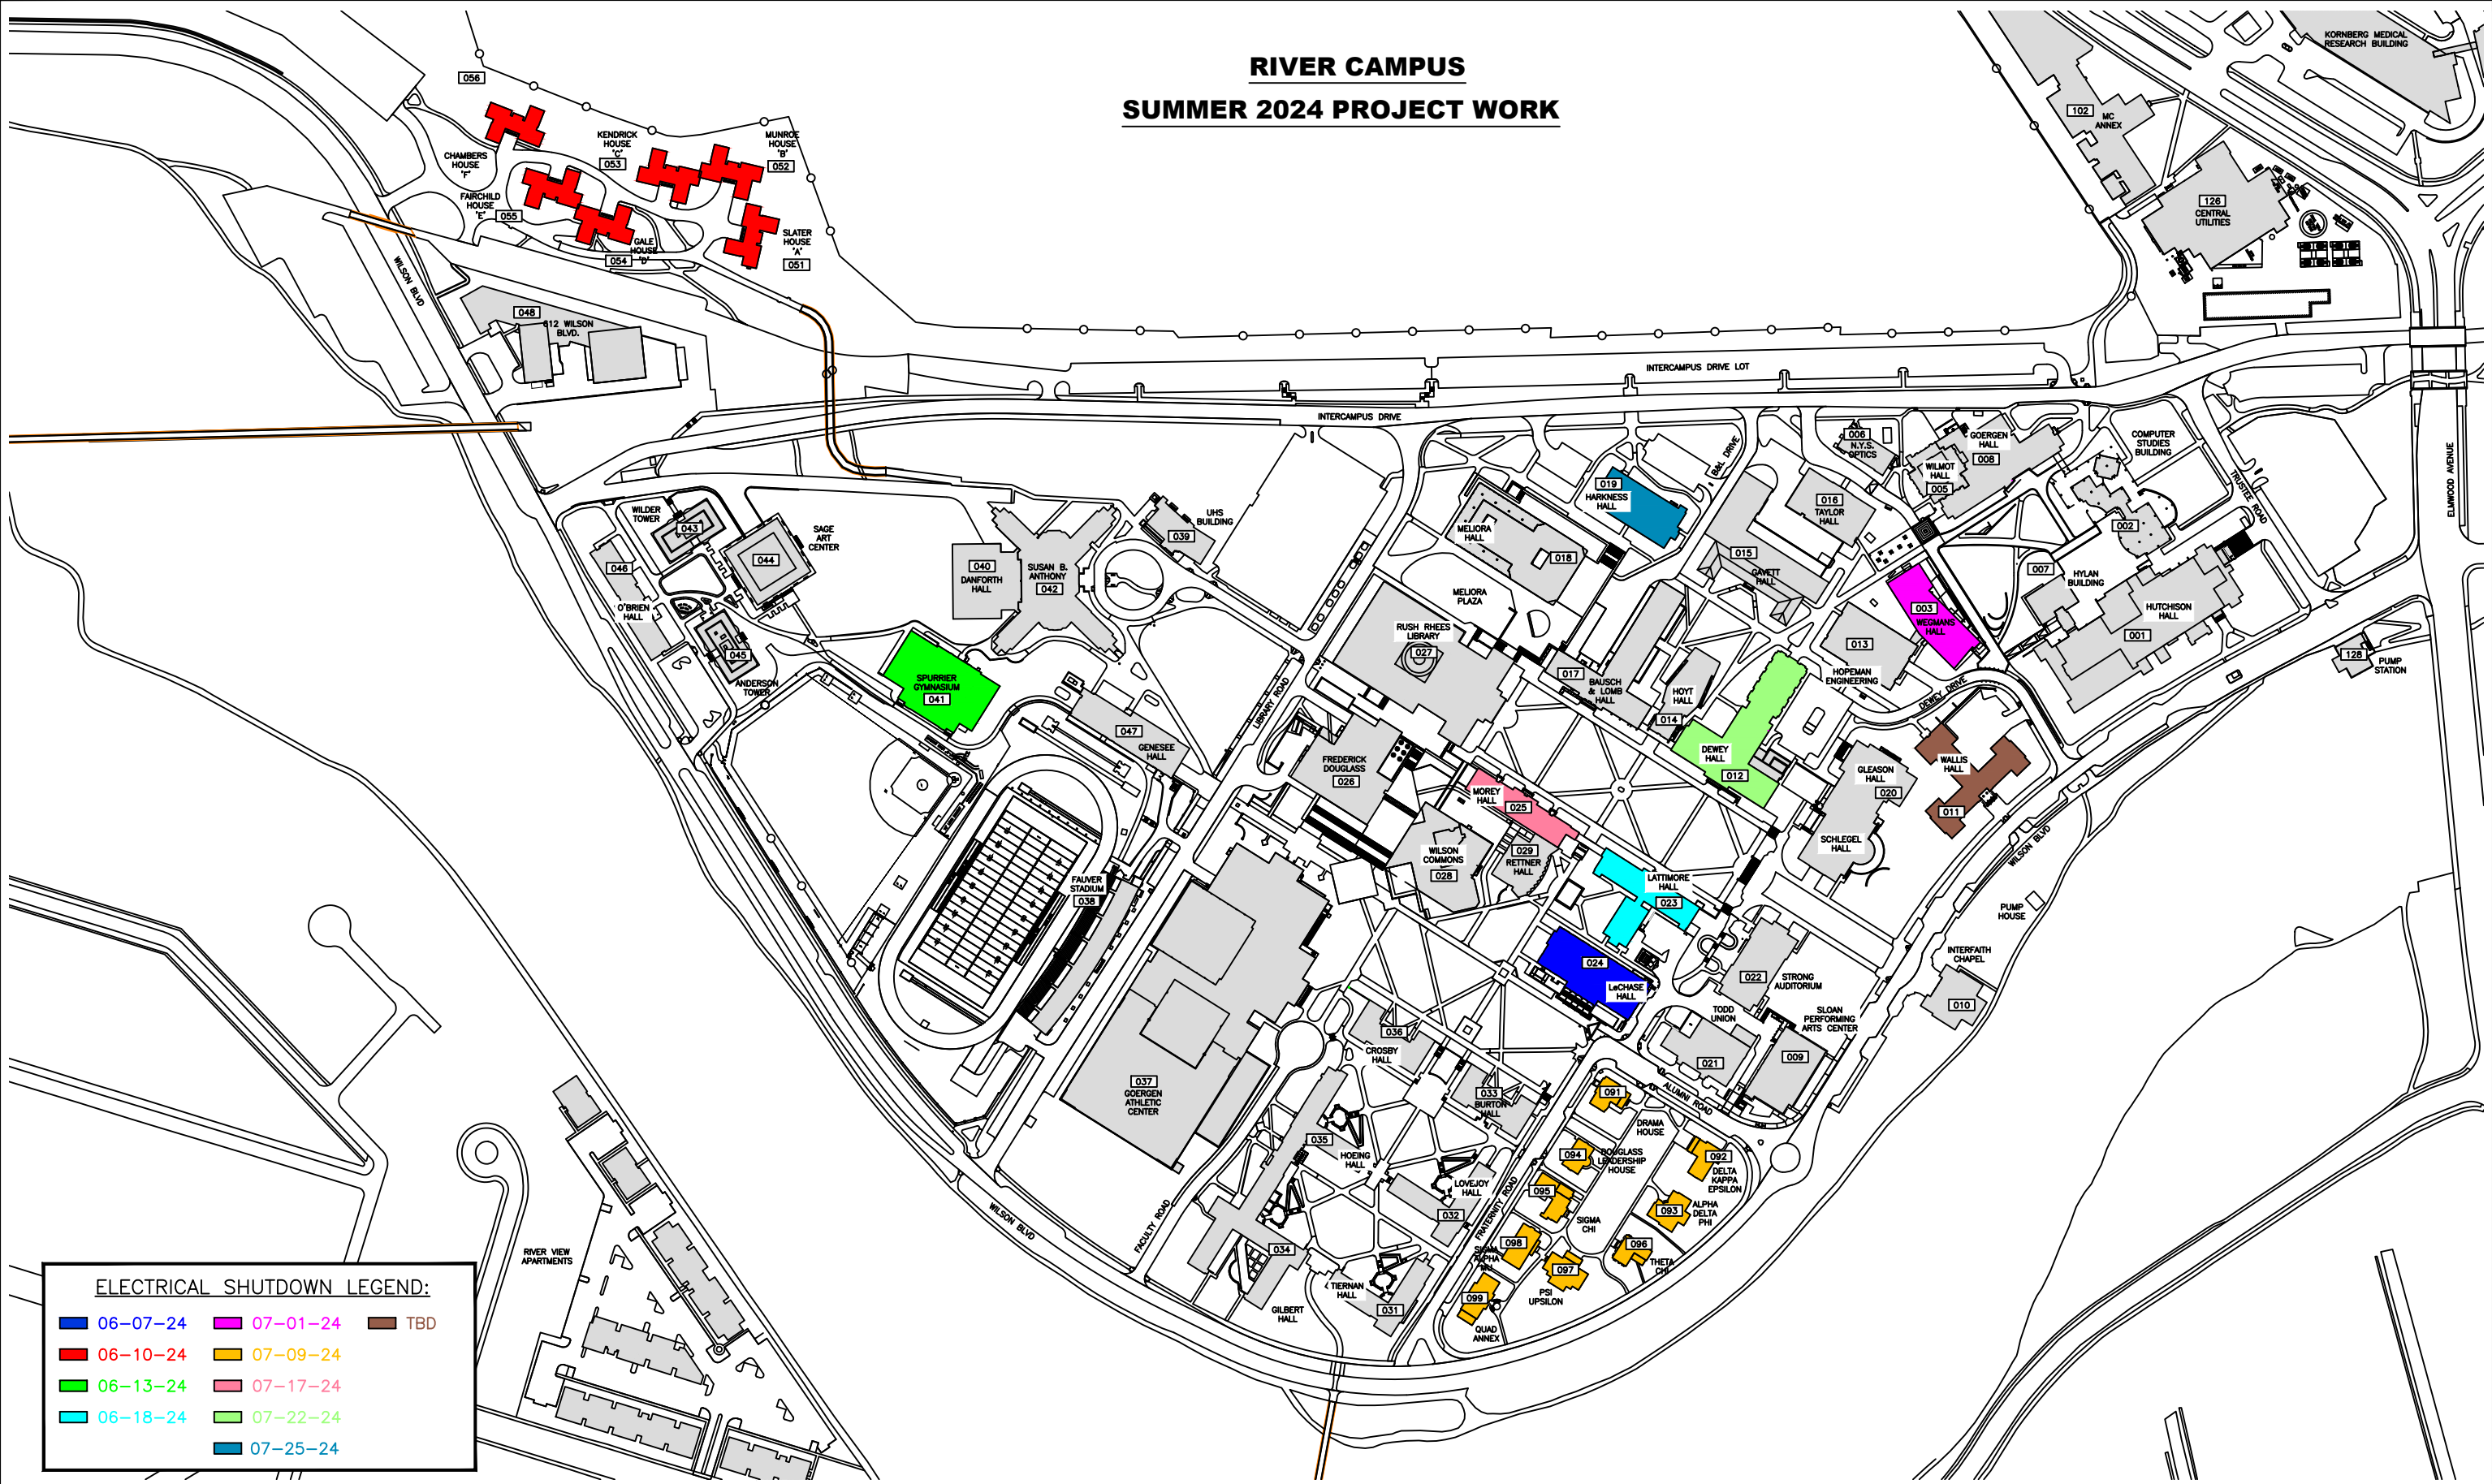

ELECTRICAL SHUTDOWN LEGEND:

06-07-24	07-01-24	TBD
06-10-24	07-09-24	
06-13-24	07-17-24	
06-18-24	07-22-24	
07-25-24		



DRAWN OR REVISED BY: KEVIN KEHOE	DRAWING NAME: RIVER CAMPUS SITE 2024 PROJECTS	BUILDING NAME: AS NOTED	DRAWING LOCATION: H:\WORKING PLANS\SITE\AUTOCAD BASE SITE DRAWINGS\ RIVER CAMPUS SITE PLANS\RC 2024 SUMMER PROJECTS
DATE DRAWN OR REVISED: 05-13-24	DRAWING SCALE: NOT TO SCALE	BUILDING NUMBER: AS NOTED	PLANNING AND PROJECT MANAGEMENT