


# RIVER CAMPUS SUMMER 2025 PROJECT WORK

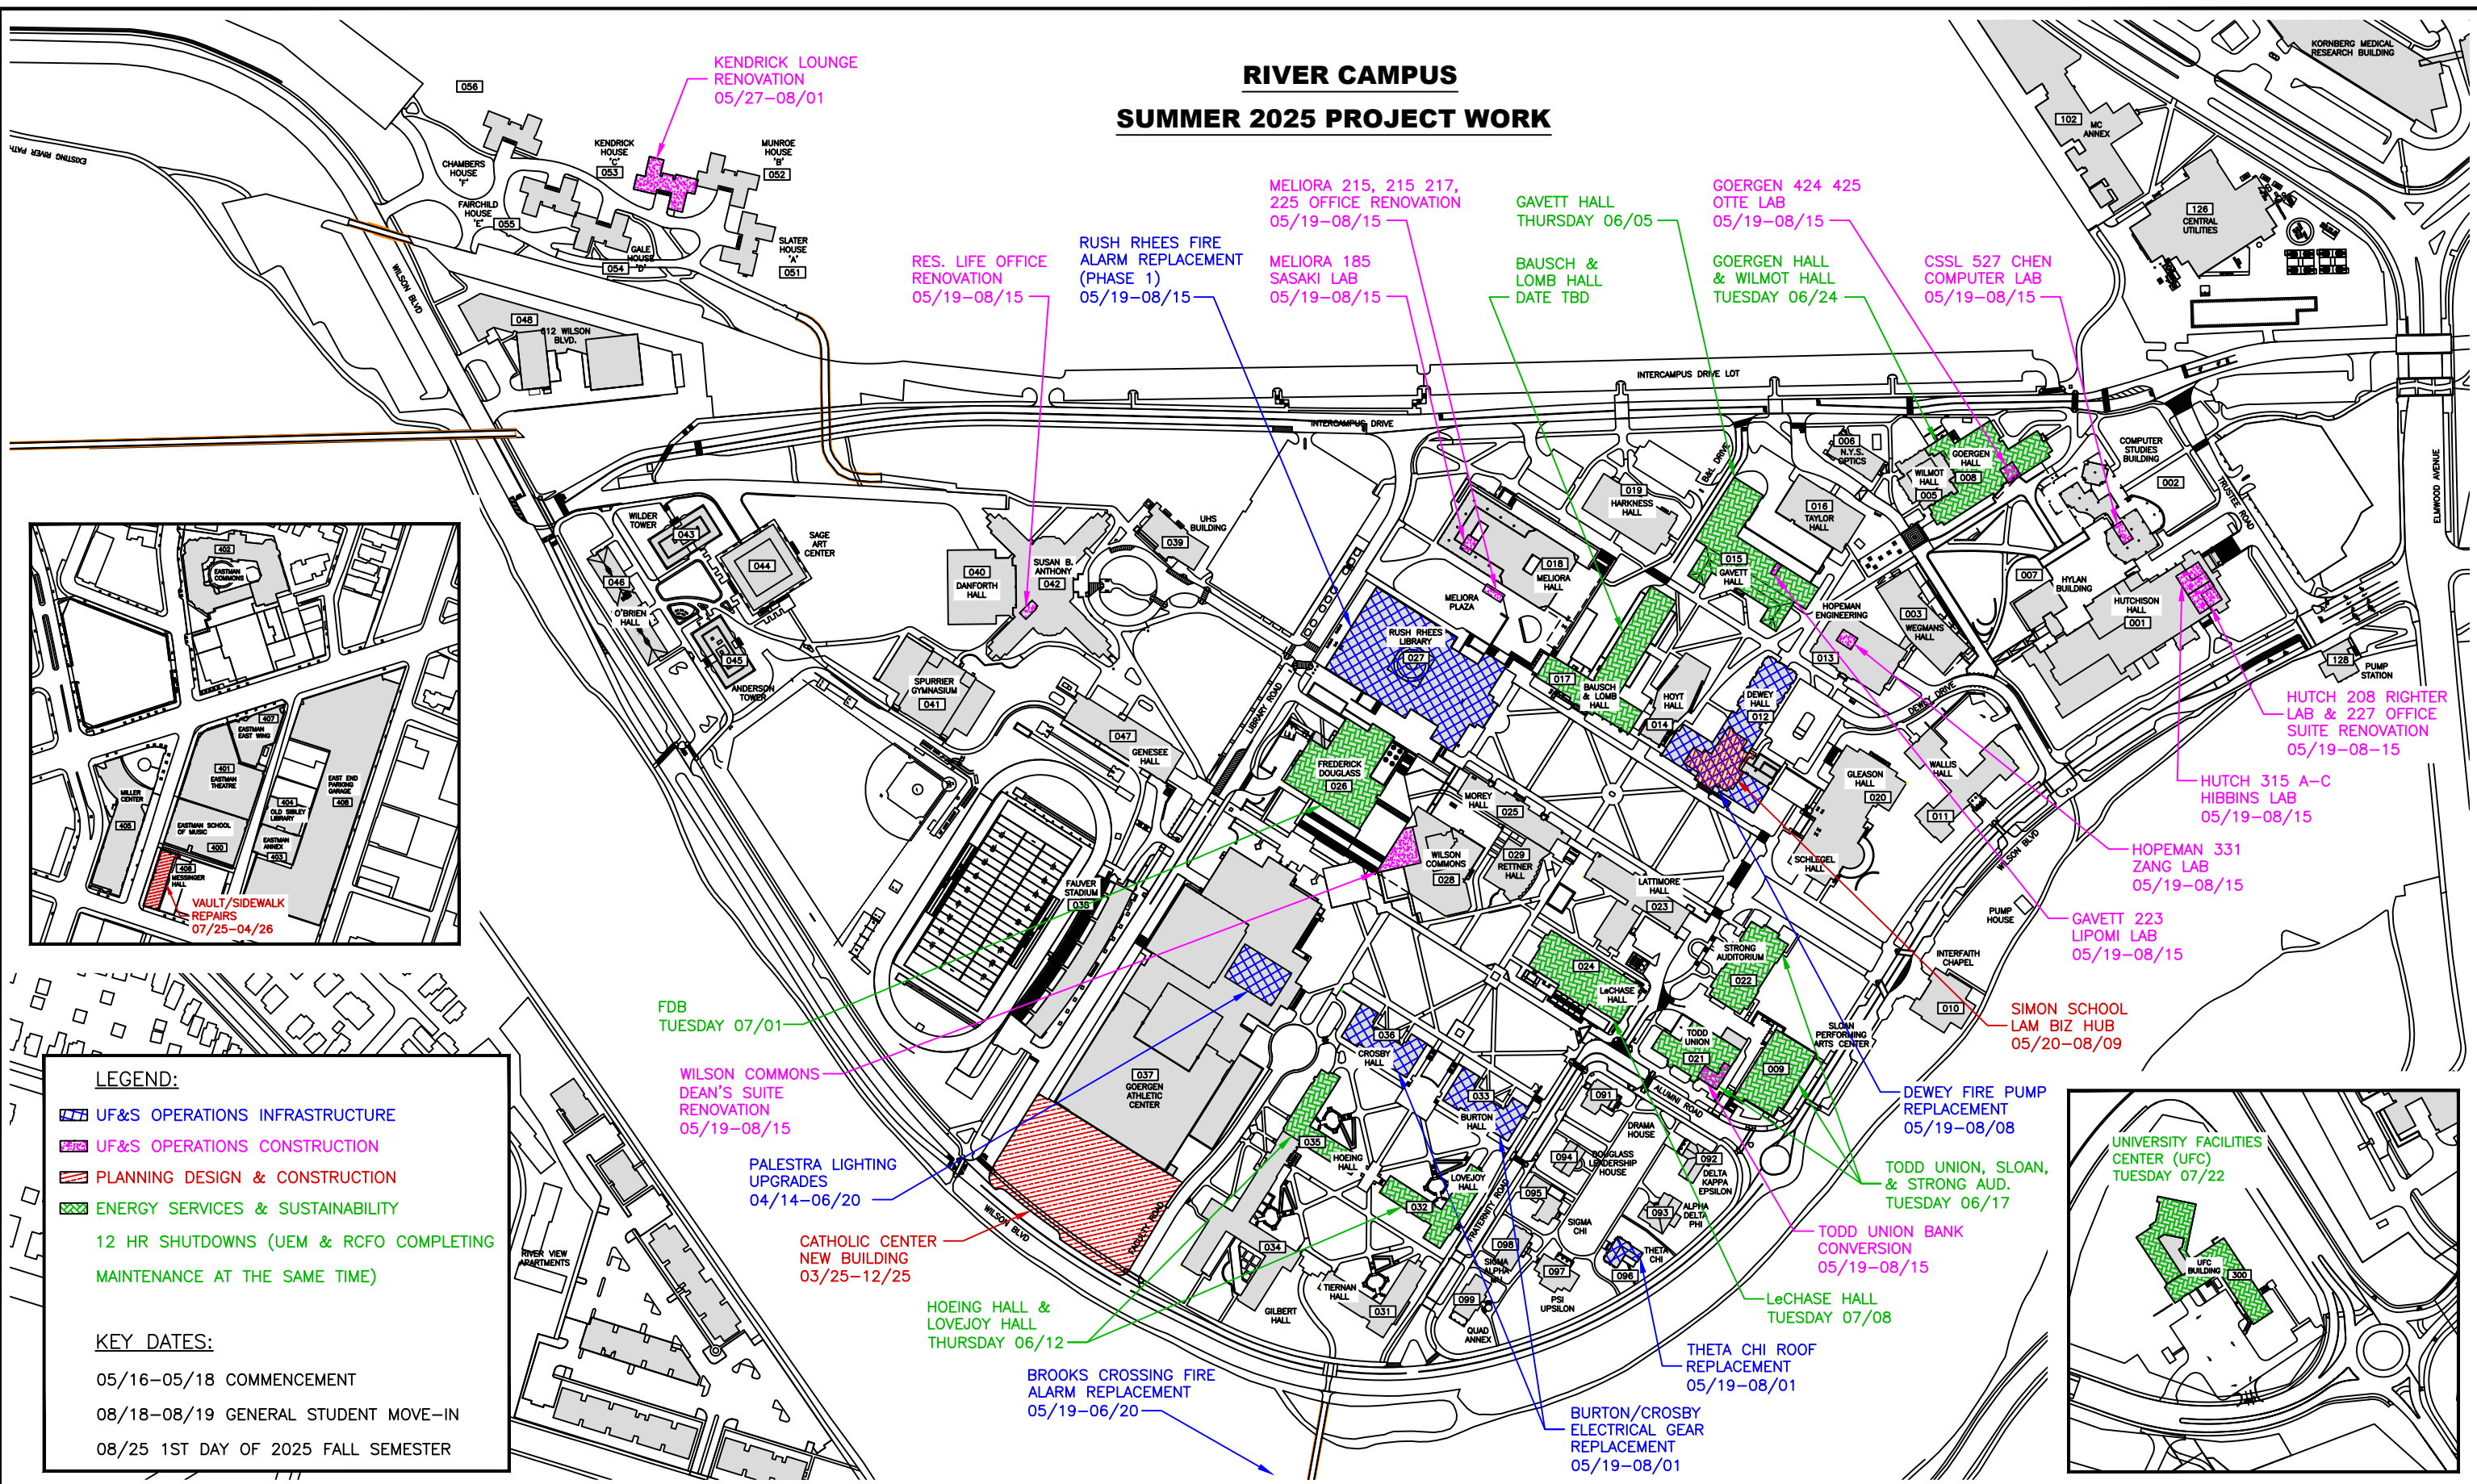

- KENDRICK LOUNGE RENOVATION 05/27-08/01
- MELIORA 215, 215 217, 225 OFFICE RENOVATION 05/19-08/15
- GAVETT HALL THURSDAY 06/05
- GOERGEN 424 425 OTTE LAB 05/19-08/15
- GOERGEN HALL & WILMOT HALL TUESDAY 06/24
- CSSL 527 CHEN COMPUTER LAB 05/19-08/15
- HUTCH 208 RIGHTER LAB & 227 OFFICE SUITE RENOVATION 05/19-08-15
- HUTCH 315 A-C HIBBINS LAB 05/19-08/15
- HOPEMAN 331 ZANG LAB 05/19-08/15
- GAVETT 223 LIPOMI LAB 05/19-08/15
- SIMON SCHOOL LAM BIZ HUB 05/20-08/09
- DEWEY FIRE PUMP REPLACEMENT 05/19-08/08
- TODD UNION, SLOAN, & STRONG AUD. TUESDAY 06/17
- TODD UNION BANK CONVERSION 05/19-08/15
- LeCHASE HALL TUESDAY 07/08
- THETA CHI ROOF REPLACEMENT 05/19-08/01
- BURTON/CROSBY ELECTRICAL GEAR REPLACEMENT 05/19-08/01
- BROOKS CROSSING FIRE ALARM REPLACEMENT 05/19-06/20
- HOEING HALL & LOVEJOY HALL THURSDAY 06/12
- CATHOLIC CENTER NEW BUILDING 03/25-12/25
- PALESTRA LIGHTING UPGRADES 04/14-06/20
- WILSON COMMONS DEAN'S SUITE RENOVATION 05/19-08/15
- FDB TUESDAY 07/01
- RES. LIFE OFFICE RENOVATION 05/19-08/15
- RUSH RHEES FIRE ALARM REPLACEMENT (PHASE 1) 05/19-08/15
- MELIORA 185 SASAKI LAB 05/19-08/15
- BAUSCH & LOMB HALL DATE TBD
- GOERGEN HALL & WILMOT HALL TUESDAY 06/24
- GOERGEN 424 425 OTTE LAB 05/19-08/15
- CSSL 527 CHEN COMPUTER LAB 05/19-08/15
- HUTCH 208 RIGHTER LAB & 227 OFFICE SUITE RENOVATION 05/19-08-15
- HUTCH 315 A-C HIBBINS LAB 05/19-08/15
- HOPEMAN 331 ZANG LAB 05/19-08/15
- GAVETT 223 LIPOMI LAB 05/19-08/15
- SIMON SCHOOL LAM BIZ HUB 05/20-08/09
- DEWEY FIRE PUMP REPLACEMENT 05/19-08/08
- TODD UNION, SLOAN, & STRONG AUD. TUESDAY 06/17
- TODD UNION BANK CONVERSION 05/19-08/15
- LeCHASE HALL TUESDAY 07/08
- THETA CHI ROOF REPLACEMENT 05/19-08/01
- BURTON/CROSBY ELECTRICAL GEAR REPLACEMENT 05/19-08/01
- BROOKS CROSSING FIRE ALARM REPLACEMENT 05/19-06/20
- HOEING HALL & LOVEJOY HALL THURSDAY 06/12
- CATHOLIC CENTER NEW BUILDING 03/25-12/25
- PALESTRA LIGHTING UPGRADES 04/14-06/20
- WILSON COMMONS DEAN'S SUITE RENOVATION 05/19-08/15
- FDB TUESDAY 07/01

**LEGEND:**

- UF&S OPERATIONS INFRASTRUCTURE
- UF&S OPERATIONS CONSTRUCTION
- PLANNING DESIGN & CONSTRUCTION
- ENERGY SERVICES & SUSTAINABILITY
- 12 HR SHUTDOWNS (UEM & RCFO COMPLETING MAINTENANCE AT THE SAME TIME)

**KEY DATES:**

- 05/16-05/18 COMMENCEMENT
- 08/18-08/19 GENERAL STUDENT MOVE-IN
- 08/25 1ST DAY OF 2025 FALL SEMESTER



|  |   |                                     |  |
|--|---|-------------------------------------|--|
| <b>DRAWN OR REVISED BY:</b><br>KEVIN KEHOE | <b>DRAWING NAME:</b><br>RIVER CAMPUS SITE 2025 PROJECTS | <b>BUILDING NAME:</b><br>AS NOTED   | <b>DRAWING LOCATION:</b><br>H:\WORKING PLANS\SITE\AUTOCAD BASE SITE DRAWINGS\RIVER CAMPUS SITE PLANS\RC 2025 SUMMER PROJECTS |
| <b>DATE DRAWN OR REVISED:</b><br>05-08-25  | <b>DRAWING SCALE:</b><br>NOT TO SCALE                   | <b>BUILDING NUMBER:</b><br>AS NOTED | <b>PLANNING AND PROJECT MANAGEMENT</b>   |